




REFLECTED CEILING PLAN OF AUDITORIUM
SCALE 3/8" = 1'-0"

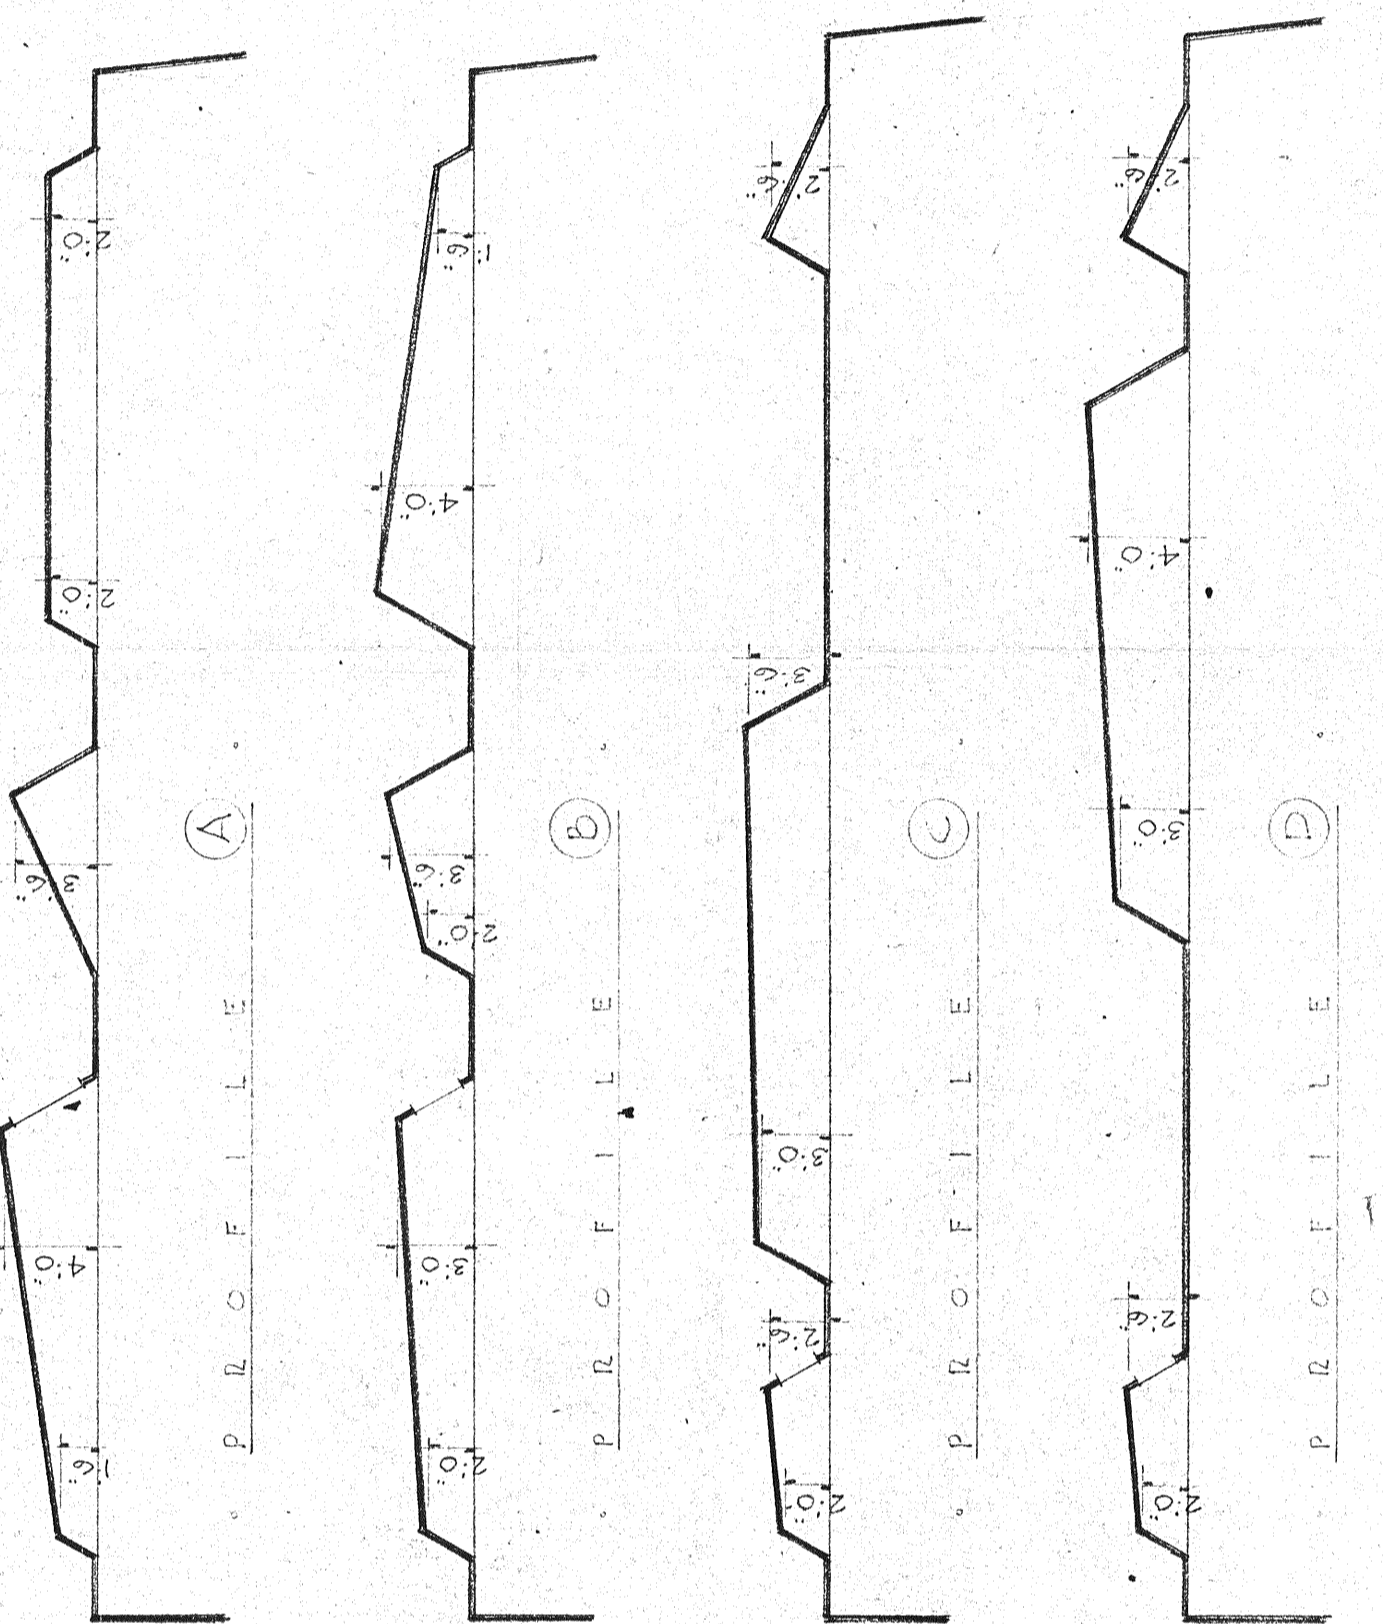


PROFILES OF AUDITORIUM CEILING
SCALE 3/8" = 1'-0"

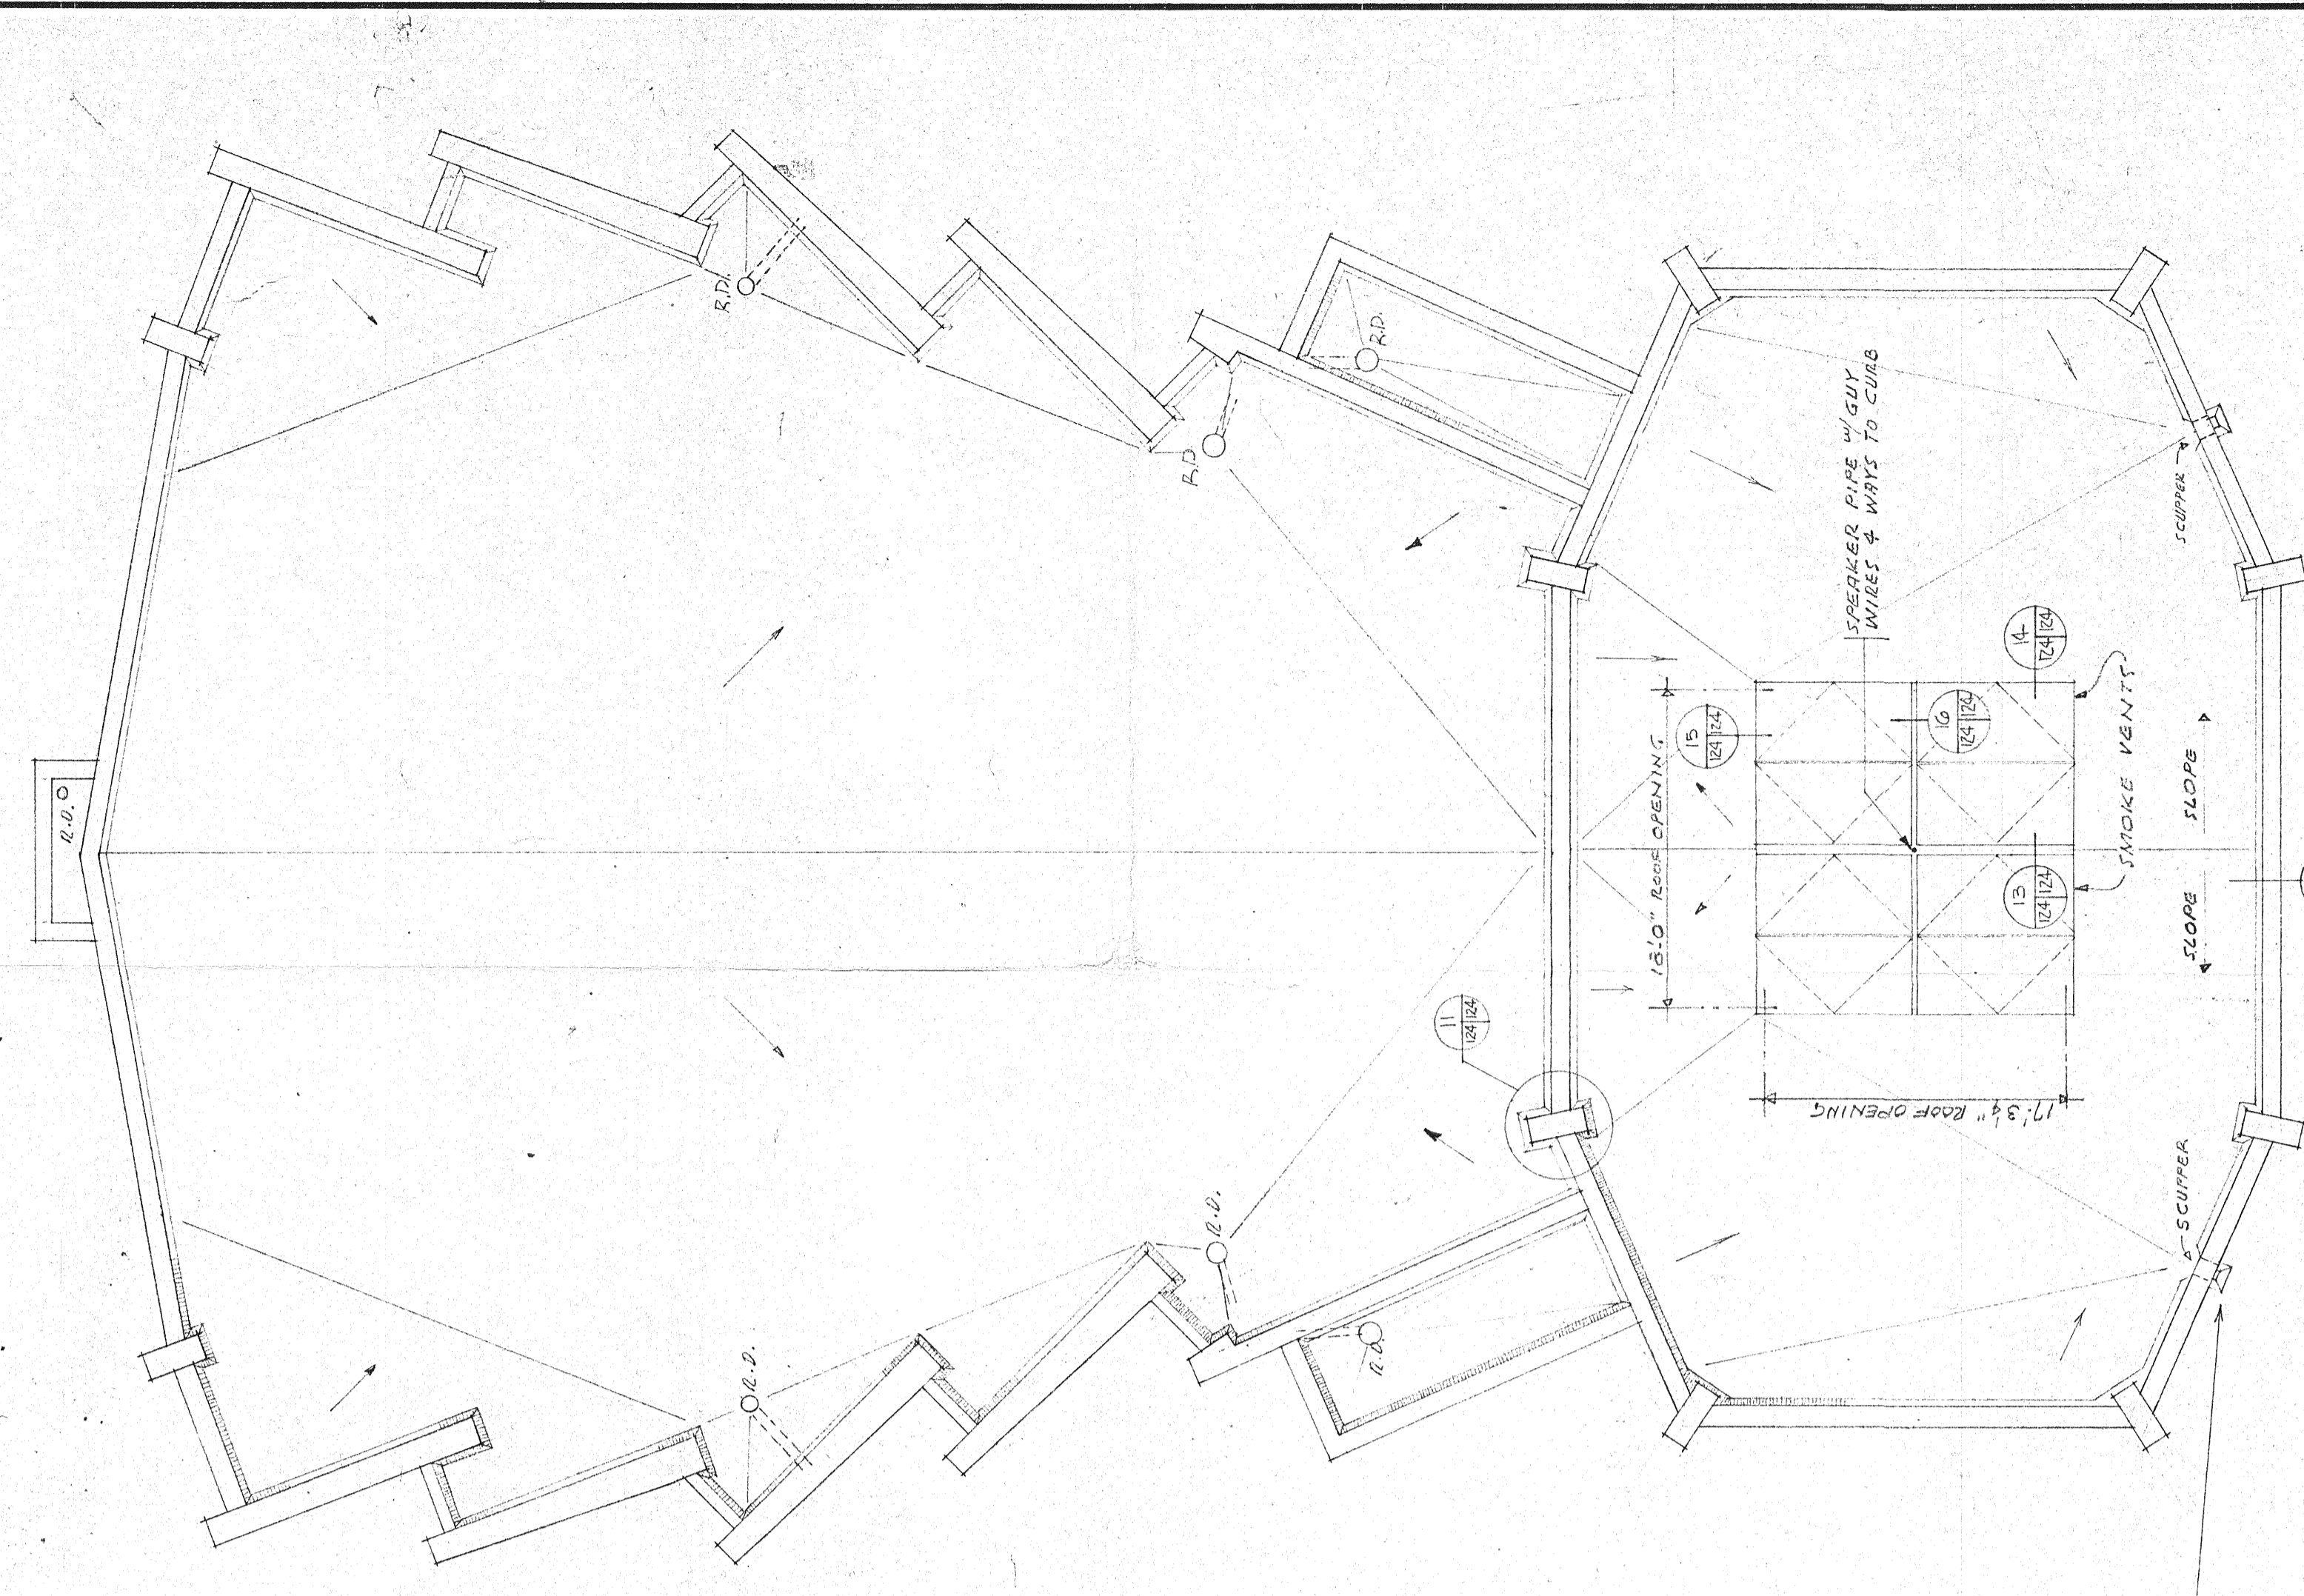


UPPER ROOF PLAN SCALE 3/8" = 1'-0"

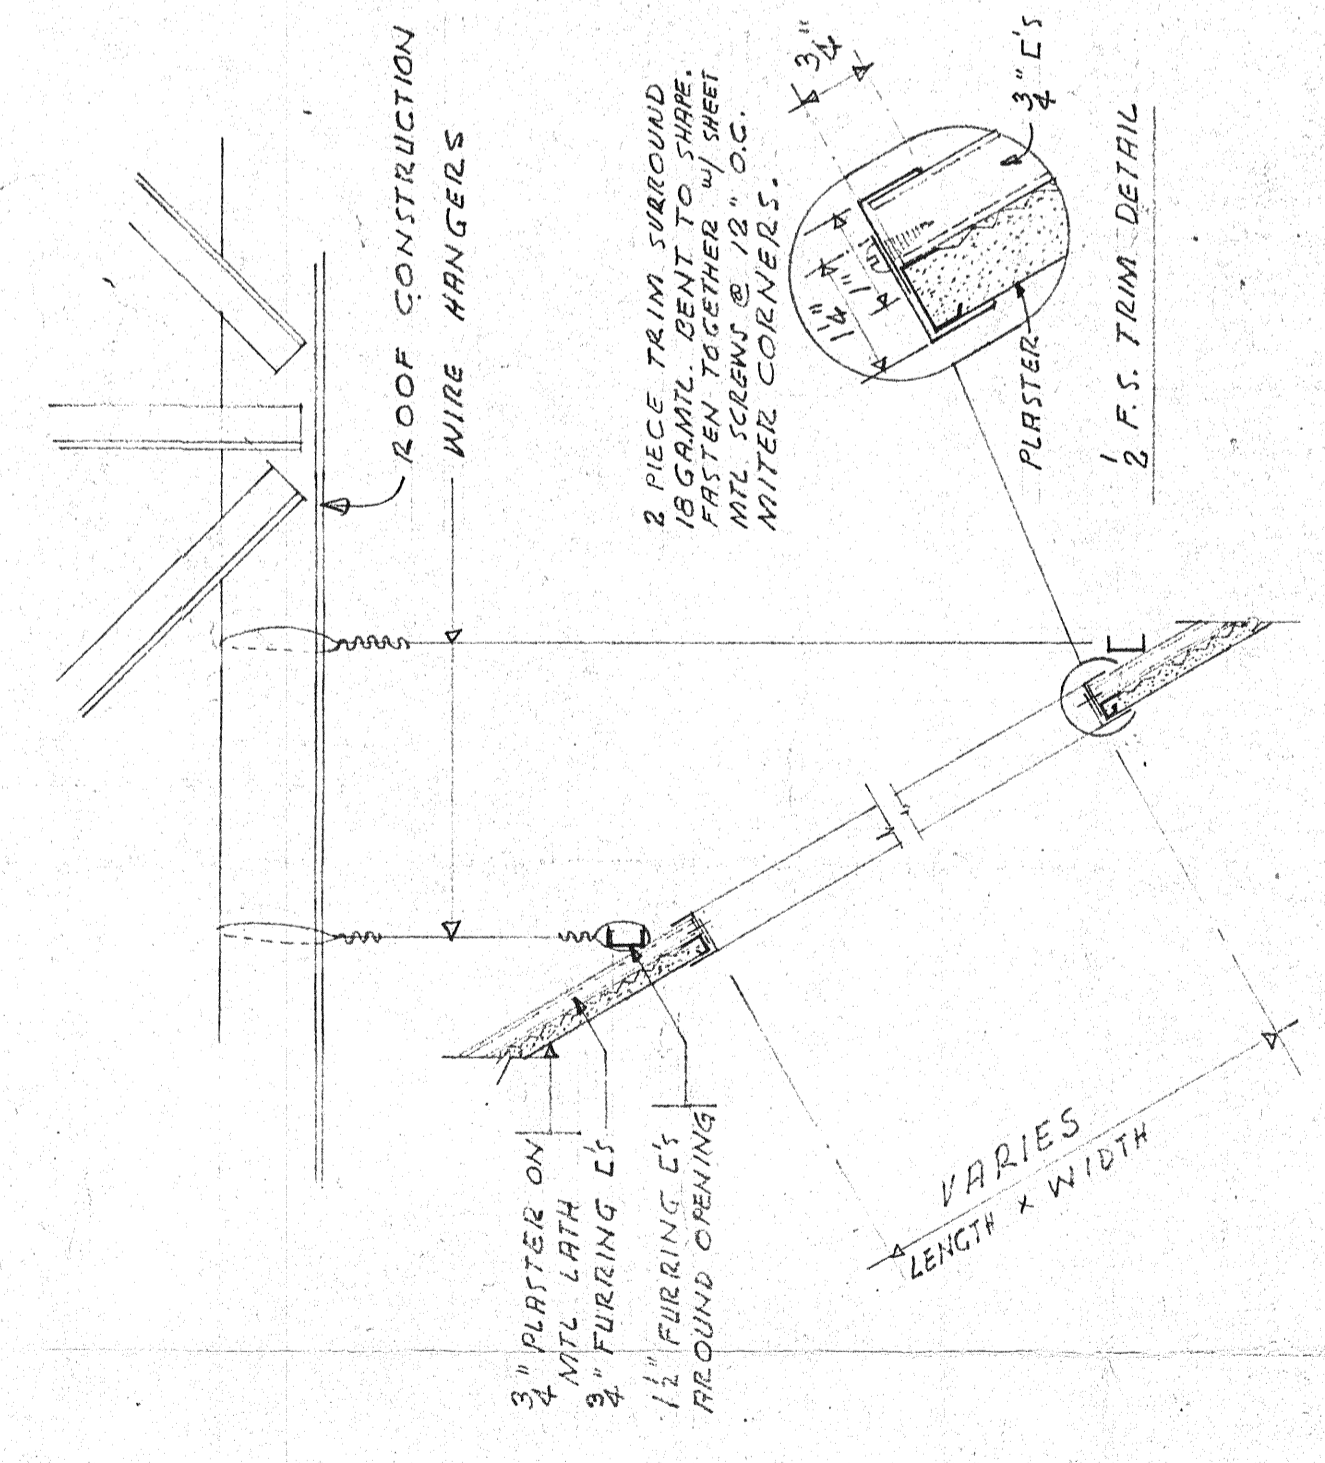


SECTION 9 AT CEILING

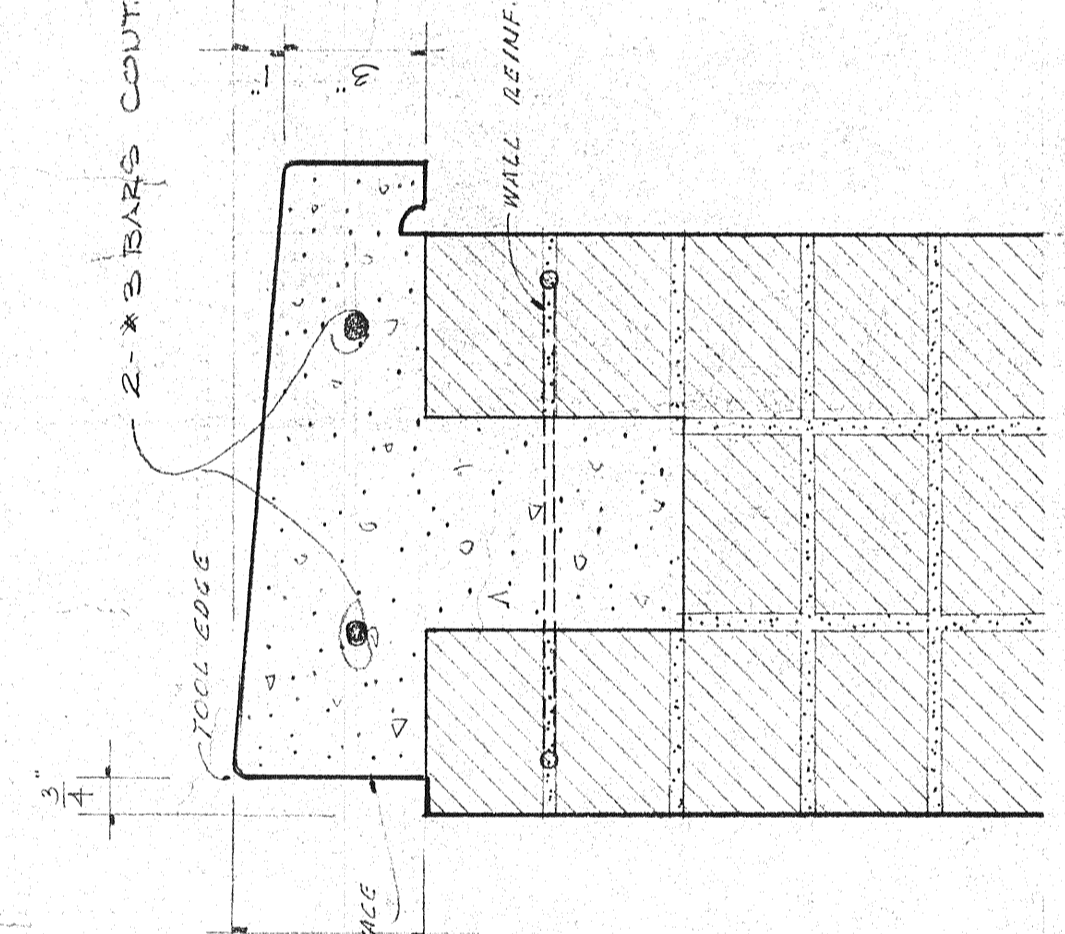


TYPICAL CONCRETE COPING
SCALE 3/8" = 1'-0"

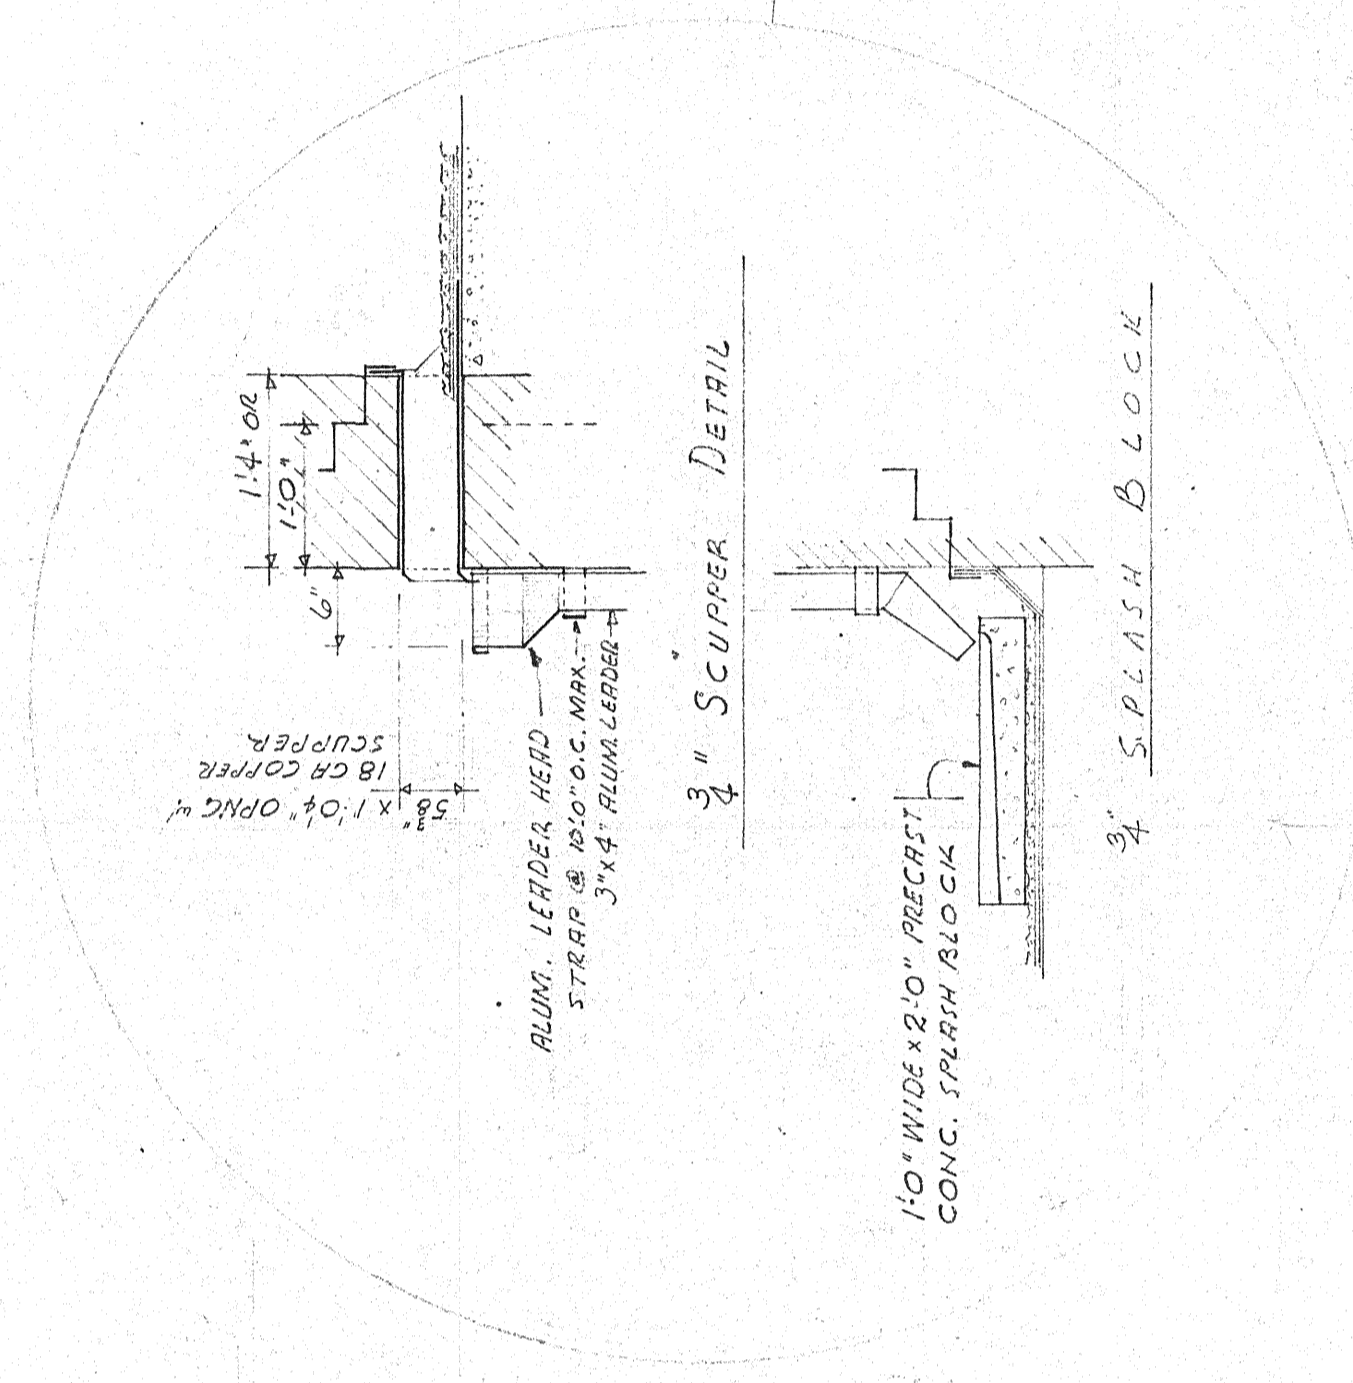



SCUPPER DETAIL

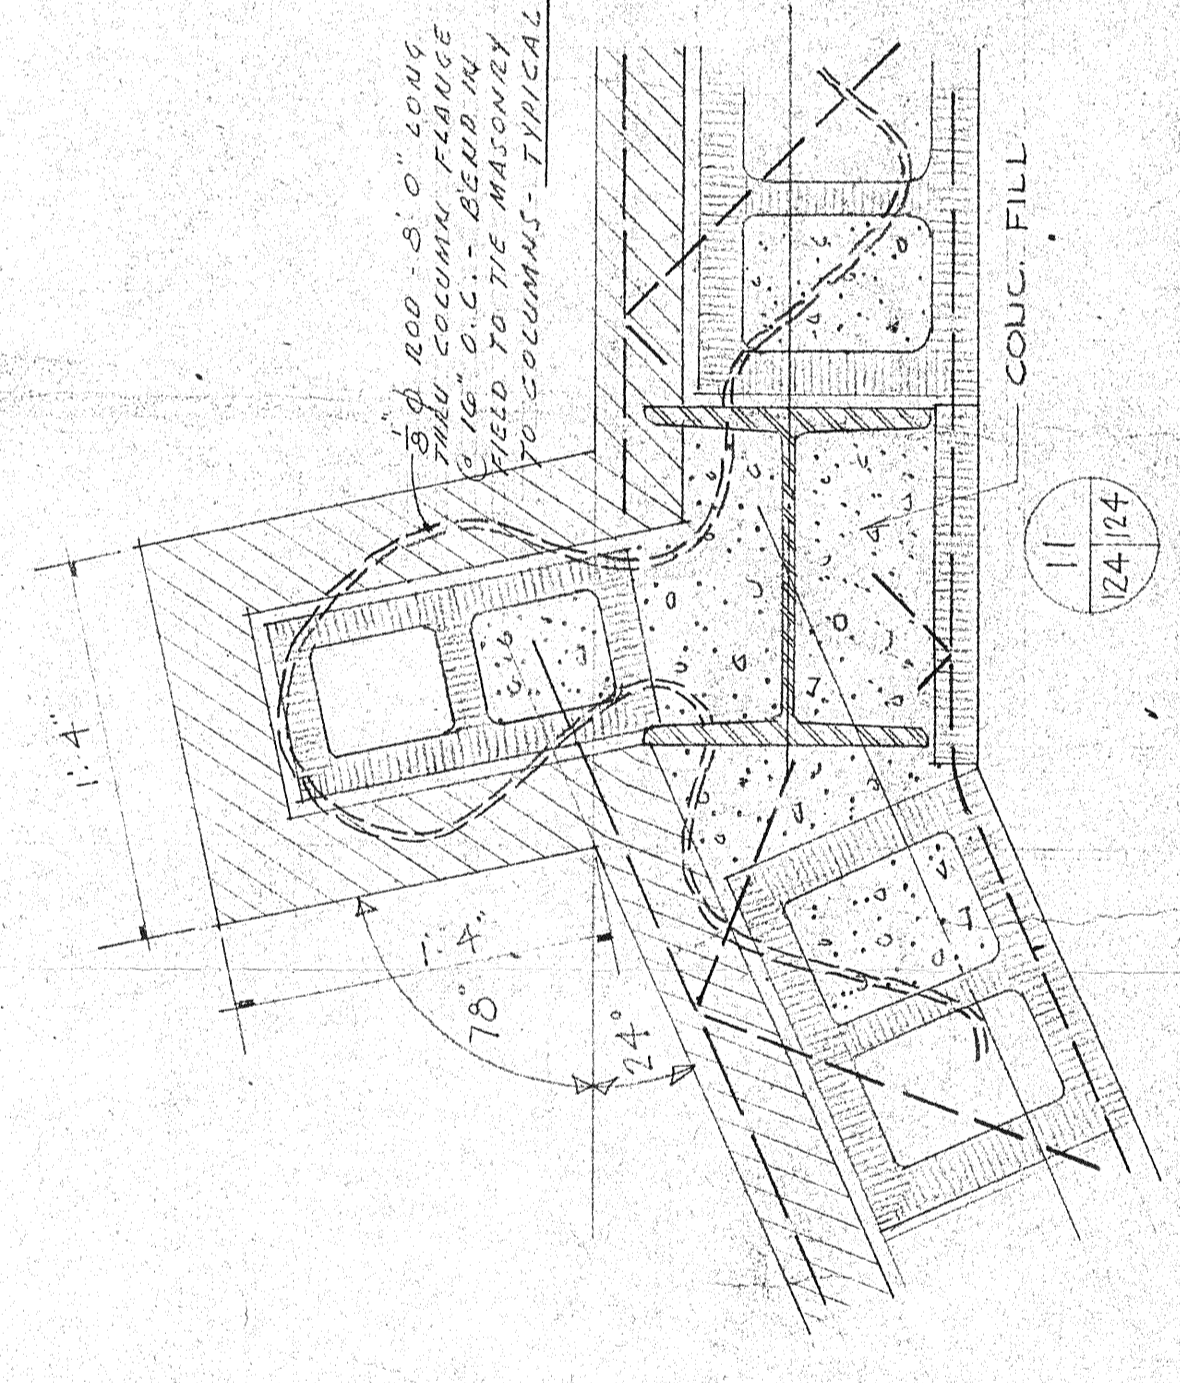

PILASTER @ STAGE SHAFT ABOVE LOWER ROOF LEVEL
SCALE 1/2" = 1'-0"

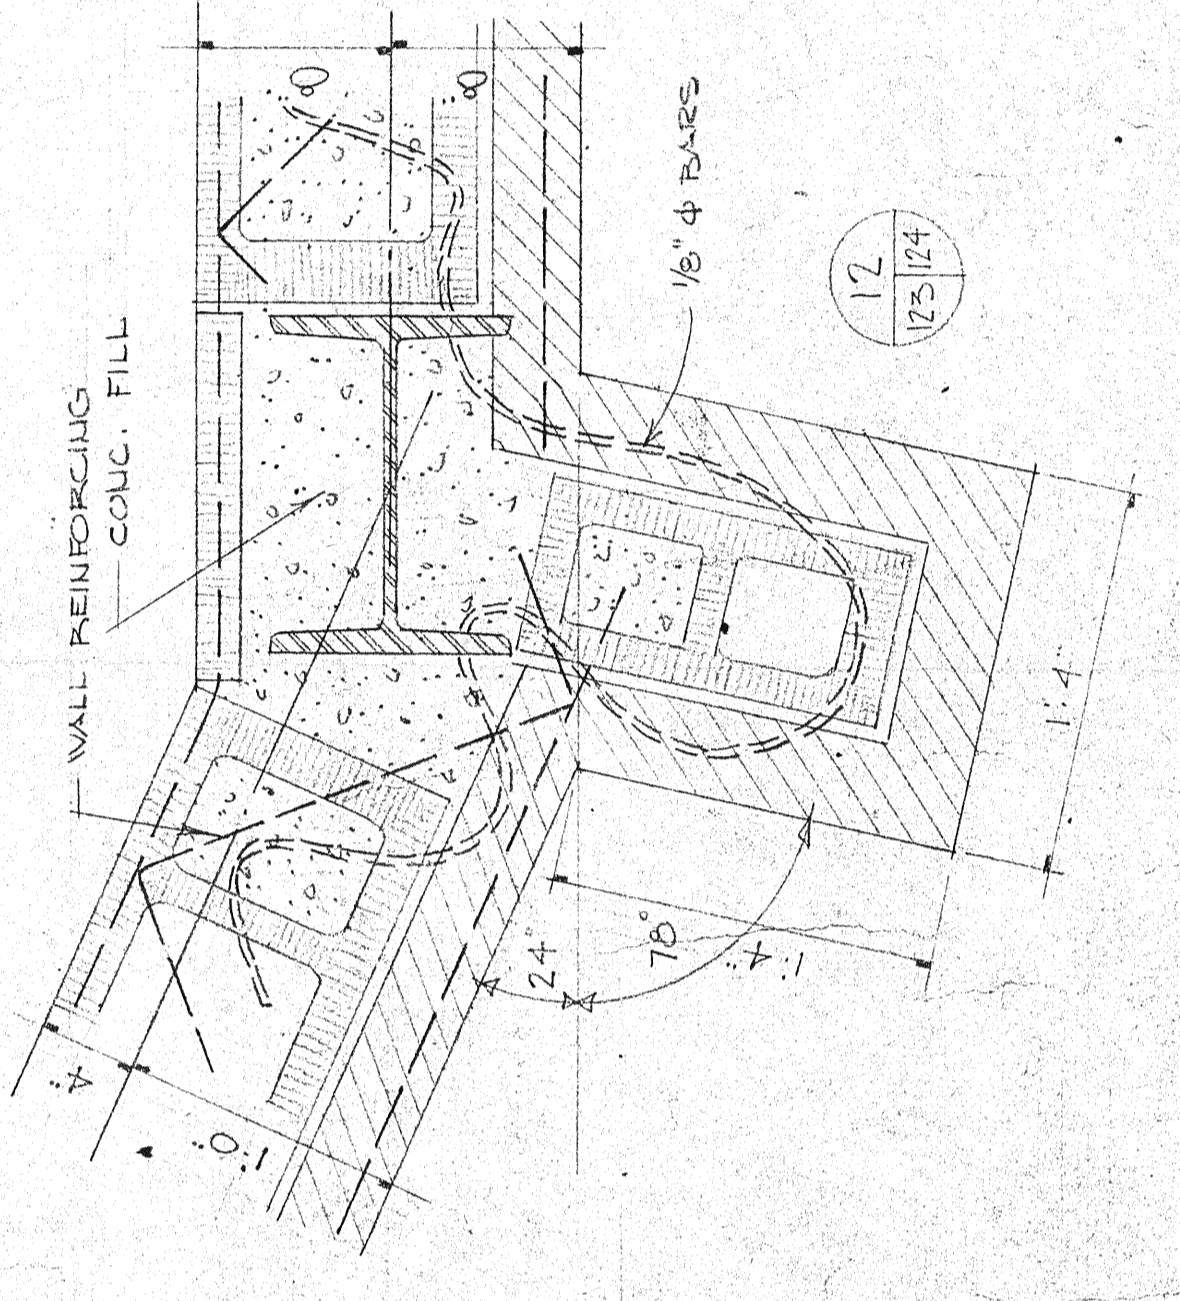

PILASTER @ STAGE SHAFT ABOVE LOWER ROOF LEVEL
SCALE 1/2" = 1'-0"

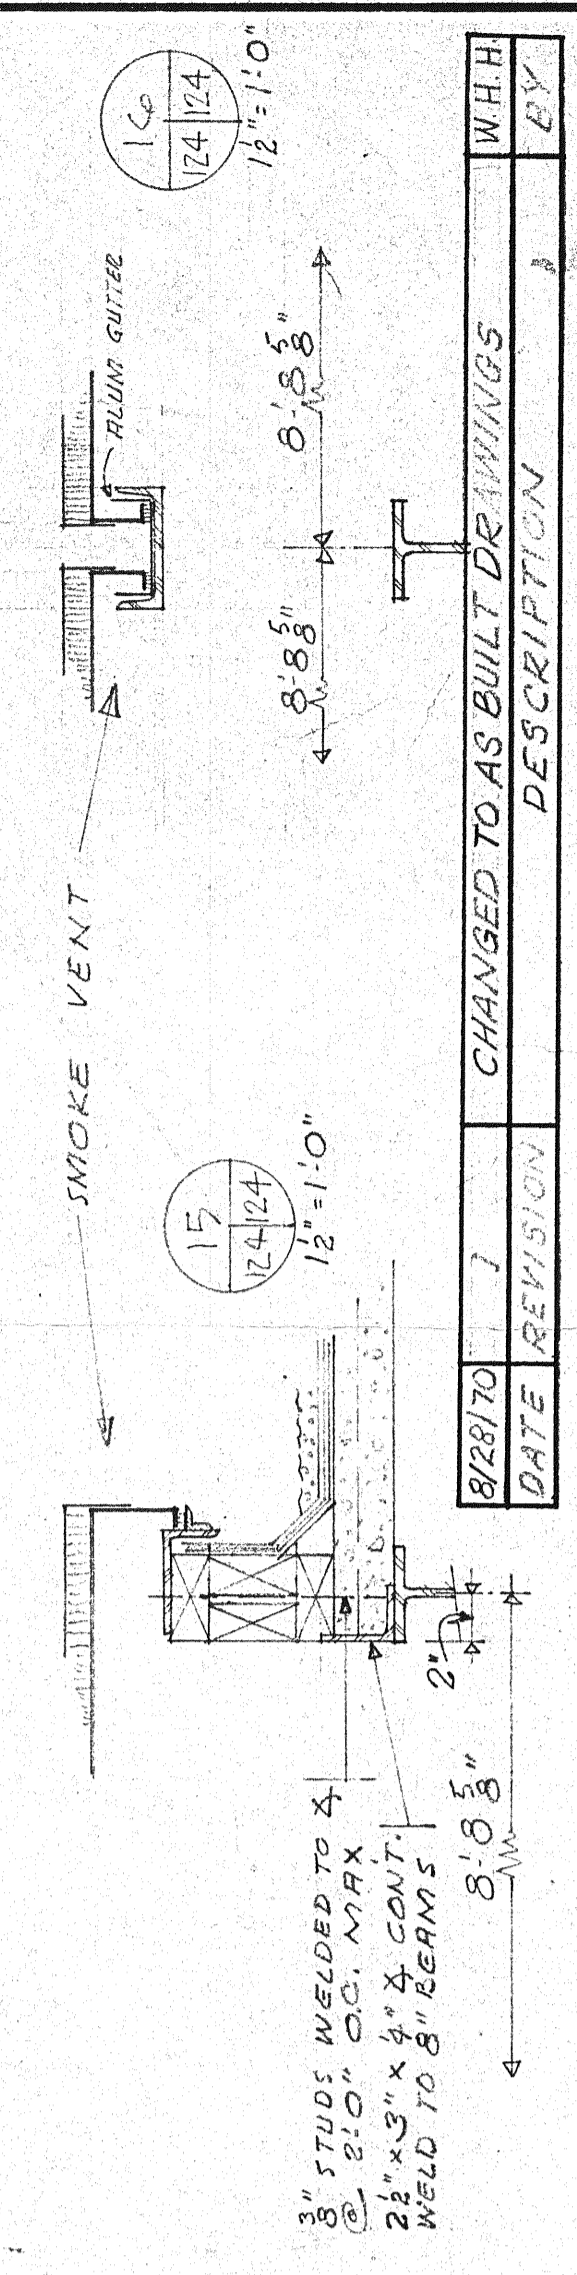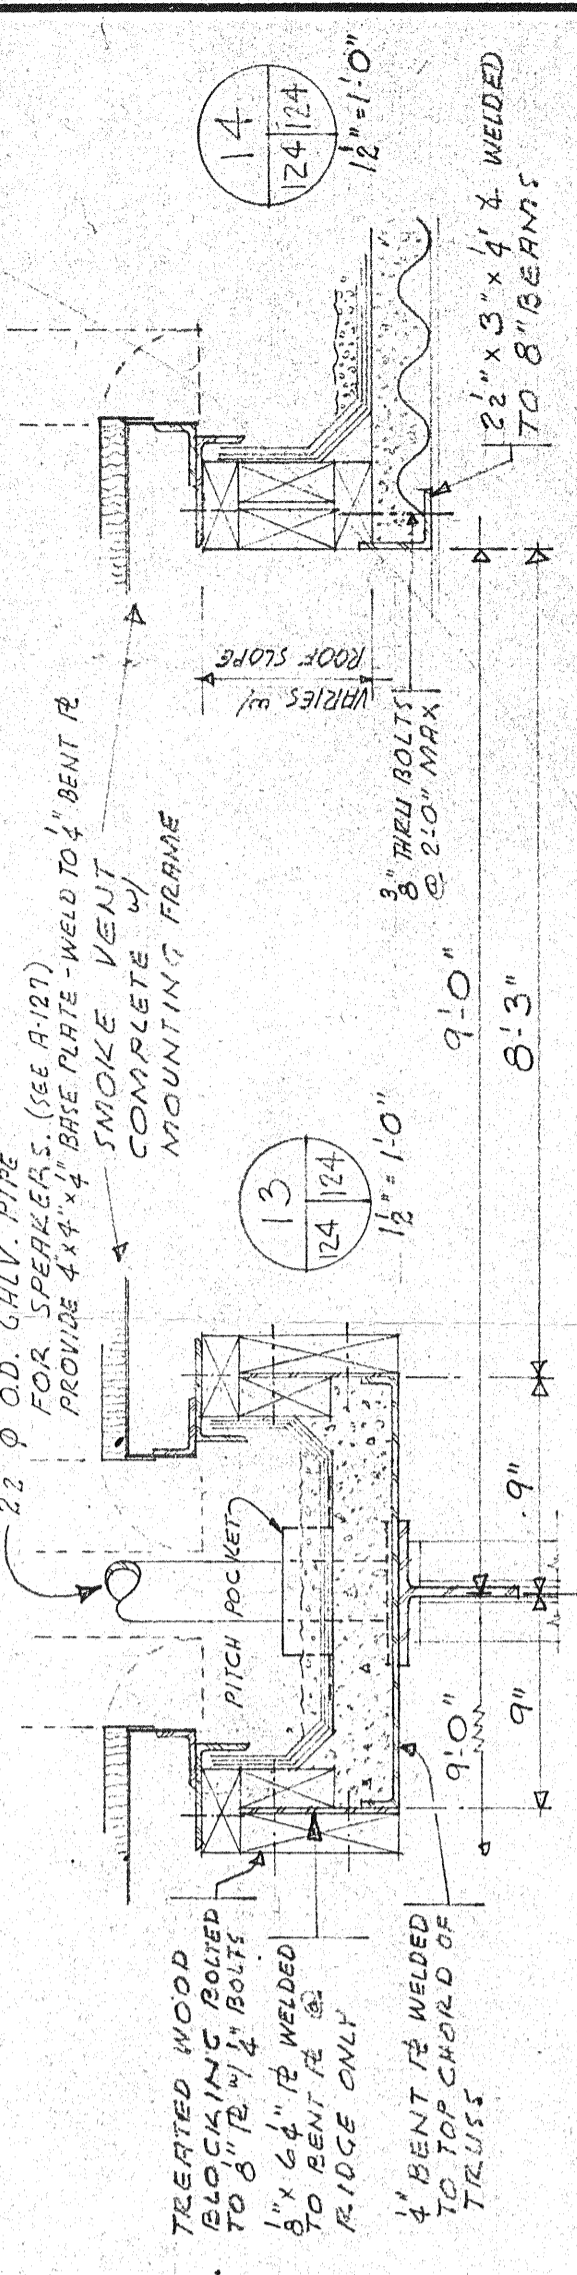

SMOKE VENT

DATE	REVISION	DESCRIPTION	WHH
8/29/70	7	CHANGED TO AS BUILT DRAWINGS	2/2

GEORGIA RETARDATION CENTER
DEKALB COUNTY, GEORGIA
GEORGIA DEPARTMENT OF PUBLIC HEALTH

JOINT AND ASSOCIATES
ARCHITECTS
AND
ENGINEERS
AUGUSTA, GEORGIA

BUILDING L
REFLECTED CEILING & UPPER ROOF PLAN
DWG. NO. **A-124**
APPROVED BY: [Signature]
DATE: FEB. 1966
JOB NO. 655
REVISION NO. OF 195

